 
 
 
 
 
 
 
 
 
 
 
 
 
 
 
 


C:\Users\VanDOneDrive - Geis Companies\Desktop\JM Addition\JM G-100 TITLE SHEET.dwg 07/19/2025 Ryan Bertrand 20:00

ARCHITECTURAL SYMBOL LEGEND			
	WALL TYPE		WINDOW / GLAZING TAG
	DOOR TAG		EXTERIOR FINISH / MATERIAL KEYNOTE
	SECTION CUT LABEL		ELEVATION LABEL
	DETAIL CALLOUT		INTERIOR ELEVATION LABEL
	ELEVATION / DATUM POINT		ROOM LABEL
	ENLARGED DETAIL / VIEW CALLOUT		FINISH TAG
	REVISION CLOUD		REVISION TAG
	COLUMN GRID - FACE OF EXTERIOR WALLS (BUILDING CORNERS)		CEILING TAG
	COLUMN GRID - CENTER OF STRUCTURAL COLUMNS		EQUIPMENT TAG

ABBREVIATIONS INDEX

ACT.	= ACOUSTICAL CEILING TILE	GA.	= GAUGE	PROJ.	= PROJECT
ADA	= AMERICANS WITH DISABILITIES ACT	GAL.	= GALLON	PROJ.	= PROJECTION
A.F.F.	= ABOVE FINISH FLOOR	GALV.	= GALVANIZED	PROP.	= PROPOSED
ALT.	= ALTERNATE	G.C.	= GENERAL CONTRACTOR	PTN.	= PARTITION
ALUM.	= ALUMINUM	GEN.	= GENERAL	P.S.F.	= POUNDS PER SQUARE FOOT
ANOD.	= ANODIZED	GYP. BD.	= GYPSUM BOARD	P.S.I.	= POUNDS PER SQUARE INCH
APPROX.	= APPROXIMATELY	H.	= HIGH	PVC	= POLYVINYL CHLORIDE
ARCH.	= ARCHITECT / ARCHITECTURAL	H/B.	= HOSE BIB	PVMT.	= PAVEMENT
AVG.	= AVERAGE	H/C	= HANDICAP	QTY.	= QUANTITY
B.F.F.	= BELOW FINISH FLOOR	H.P.	= HIGH POINT	R.	= RADIUS
B.F.G.	= BELOW FINISH GRADE	HR.	= HOUR	R.	= RISER
BLDG.	= BUILDING	HT.	= HEIGHT	RAD.	= RADIUS
B.O.	= BOTTOM OF	HVAC	= HEATING VENTILATION AIR CONDITIONING	R.P.	= REFLECTED CEILING PLAN
BRG.	= BEARING	H.W.	= HOT WATER	R.A.	= ROOF DRAIN
		H.W.R.	= HOT WATER RETURN	REF.	= REFERENCE
C/C	= CENTER TO CENTER	I.C.F.	= INSULATED CONCRETE FORM	REINF.	= REINFORCED
CABT.	= CABINET	I.D.	= INSIDE DIAMETER	REQ.	= REQUIRED / REQUIREMENT
C.F.	= CUBIC FEET	I.M.P.	= INSULATED METAL PANEL	REV.	= REVISION
C.J.	= CONTROL JOINT	IN.	= INCH	RFG.	= REFRIGERATOR
CLG.	= CEILING	INUL.	= INSULATION	RM.	= ROOM
CLR.	= CLEAR	JAN.	= JANITOR	R.O.	= ROUGH OPENING
C.M.U.	= CONCRETE MASONRY UNIT	JST.	= JOIST	R.T.U.	= ROOF TOP UNIT
CNPY	= CANOPY	JT.	= JOINT	R/W	= RIGHT OF WAY
CNTR.	= COUNTER	L	= LONG	S	= SOUTH
C.O.	= CLEAN OUT	L	= LENGTH	SAN.	= SANITARY
COL.	= COLUMN	LAM.	= LAMINATE	SCHED.	= SCHEDULE
CONC.	= CONCRETE	LAV.	= LAVATORY	SECT.	= SECTION
CONST.	= CONSTRUCTION	LBS.	= POUNDS	S.F.	= SQUARE FEET
CONT.	= CONTINUOUS	LF.	= LINEAR FOOT	SHT.	= SHEET
D	= DEPTH	L.L.H.	= LONG LEG HORIZONTAL	SHWR.	= SHOWER
DBL	= DOUBLE	L.L.V.	= LONG LEG VERTICAL	SIM.	= SIMILAR
DEPT.	= DEPARTMENT	L.T.	= LAUNDRY TRAY	SPEC.	= SPECIFICATION
D.F.	= DRINKING FOUNTAIN	MAX.	= MAXIMUM	SPECS.	= SPECIFICATIONS
DIA.	= DIAMETER	MAQ.	= MAXIMUM ALLOWABLE QUANTITY PER CONTROL AREA	SQ.FT.	= SQUARE FEET
DIM.	= DIMENSION	M.B.	= MOP BASIN	S.S.	= STAINLESS STEEL
DN.	= DOWN	MECH.	= MECHANICAL	STD.	= STANDARD
D.O.	= DOOR OPENING	MZZ.	= MEZZANINE	STL.	= STEEL
D.S.	= DOWN SPOUT	MFG.	= MANUFACTURING	STRUCT.	= STRUCTURAL
DTL.	= DETAIL	MFR.	= MANUFACTURER	SUSP.	= SUSPENDED
D.W.	= DISHWASHER	MIN.	= MINIMUM	S.Y.	= SQUARE YARD
DWGS.	= DRAWING	MISC.	= MISCELLANEOUS	SYM.	= SYMMETRICAL
DWGS.	= DRAWINGS	MM.	= MILLIMETERS	T&B	= TOP AND BOTTOM
E	= EAST	M.O.	= MASONRY OPENING	T&G	= TONGUE AND GROOVE
EA.	= EACH	MTD.	= MOUNTED	T.B.D.	= TO BE DETERMINED
EIFS	= EXTERIOR INSULATION AND FINISH SYSTEM	MTL.	= METAL	TEL.	= TELEPHONE
E.J.	= EXPANSION JOINT	N	= NORTH	TEMP.	= TEMPERED
EL	= ELEVATION	N/A	= NOT APPLICABLE	THK.	= THICK / THICKNESS
ELEC.	= ELECTRICAL	N.E.C.	= NATIONAL ELECTRIC CODE	TLT.	= TOILET
ELEV.	= ELEVATION	N.O.	= NOT IN CONTRACT	T.O.	= TOP OF
ELVTR.	= ELEVATOR	NOM.	= NOMINAL	T.P.	= TOILET PAPER
ENG.	= ENGINEERING / ENGINEERED / ENGINEER	N.T.S.	= NOT TO SCALE	TY.	= TYPICAL
EQ.	= EQUAL	O.	= ON / OVER	U.O.	= UNDERWRITERS LABORATORIES
E.T.R.	= EXISTING TO REMAIN	O.A.	= OVERALL	U.N.O.	= UNLESS NOTED OTHERWISE
E.W.	= EACH WAY	O.C.	= ON CENTER	UR.	= URINAL
EW.C.	= ELECTRIC WATER COOLER	O.D.	= OUTSIDE DIAMETER	VCT	= VINYL COMPOSITION TILE
EX	= EXISTING	OPNG.	= OPENING	VERT.	= VERTICAL
EXH	= EXHAUST	OPP.	= OPPOSITE	VEST.	= VESTIBULE
EXP.	= EXPANSION	O.VHD.	= OVERHEAD	V.I.F.	= VERIFY IN FIELD
EXT.	= EXISTING	P.C.	= PLUMBING CONTRACTOR	W	= WEST
EXTR.	= EXTERIOR	PERF.	= PERFORATED	W	= WIDTH
F.D.	= FLOOR DRAIN	PERP.	= PERPENDICULAR	W/O	= WITHOUT
F.E.	= FIRE EXTINGUISHER	PL.	= PLATE	W.C.	= WATER CLOSET
F.E.C.	= FIRE EXTINGUISHER CABINET	P/L	= PROPERTY LINE	W.	= WOOD
F.F.	= FINISH FLOOR	PLB.	= PLASTIC LAMINATE	WT.	= WEIGHT
FIN.	= FINISHED	PLAM.	= PLASTIC LAMINATE	W.W.F.	= WELDED WIRE FABRIC
FIXT.	= FIXTURE	PLYWD.	= PLYWOOD	W.W.M.	= WELDED WIRE MESH
FLR.	= FLOOR	P.N.L.	= PANEL		
FND.	= FOUNDATION	PREFAB.	= PREFABRICATED		
F.O.	= FINISH OPENING	PR.	= PAIR		
F.P.H.B.	= FROST PROOF HOSE BIBB				
F.R.T.	= FIRE RETARDANT TREATED				
FT.	= FOOT / FEET				

MATERIALS INDEX			
	BRICK VENEER		INSULATION BATT
	CONCRETE		INSULATION RIGID
	CONCRETE BLOCK		PLYWOOD
	EARTH/ BACK FILL		STEEL
	GYPSUM		SAND OR FILL
	GYPSUM BOARD/ DRYWALL		STUCCO



EXISTING NORTH ELEVATION



EXISTING EAST ELEVATION



EXISTING SOUTH ELEVATION



EXISTING WEST ELEVATION

ARCHITECT
GDOT DESIGN, LLC 10020 AURORA HUDSON ROAD STREETSBORO, OHIO 44241 PHONE: 330-528-3500 FAX: 330-528-0008 CONTACT: JEN DIASIO, R.A.

ARCHITECTURAL SEAL
I HEREBY CERTIFY THAT THE PORTION OF THE SUBMISSION WAS PREPARED BY ME OR UNDER MY DIRECT SUPERVISION AND RESPONSIBLE CHARGE. I AM A DULY REGISTERED ARCHITECT UNDER THE LAWS OF THIS STATE.
SIGNATURE _____ DATE _____ NAME _____ LICENSE NO. 24733/20206 EXPIRATION DATE _____

ARCHITECTURAL SEAL

I HEREBY CERTIFY THAT THE PORTION OF THE SUBMISSION WAS PREPARED BY ME OR UNDER MY DIRECT SUPERVISION AND RESPONSIBLE CHARGE. I AM A DULY REGISTERED ARCHITECT UNDER THE LAWS OF THIS STATE.

SIGNATURE _____ DATE _____
NAME _____
LICENSE NO. 24733/20206 EXPIRATION DATE _____

I HEREBY CERTIFY THAT THE PORTION OF THE SUBMISSION WAS PREPARED BY ME OR UNDER MY DIRECT SUPERVISION AND RESPONSIBLE CHARGE. I AM A DULY REGISTERED ARCHITECT UNDER THE LAWS OF THIS STATE.

ARCHITECTURAL SEAL

I HEREBY CERTIFY THAT THE PORTION OF THE SUBMISSION WAS PREPARED BY ME OR UNDER MY DIRECT SUPERVISION AND RESPONSIBLE CHARGE. I AM A DULY REGISTERED ARCHITECT UNDER THE LAWS OF THIS STATE.

SIGNATURE _____ DATE _____
NAME _____
LICENSE NO. 24733/20206 EXPIRATION DATE _____

I HEREBY CERTIFY THAT THE PORTION OF THE SUBMISSION WAS PREPARED BY ME OR UNDER MY DIRECT SUPERVISION AND RESPONSIBLE CHARGE. I AM A DULY REGISTERED ARCHITECT UNDER THE LAWS OF THIS STATE.

ARCHITECTURAL SEAL

I HEREBY CERTIFY THAT THE PORTION OF THE SUBMISSION WAS PREPARED BY ME OR UNDER MY DIRECT SUPERVISION AND RESPONSIBLE CHARGE. I AM A DULY REGISTERED ARCHITECT UNDER THE LAWS OF THIS STATE.

SIGNATURE _____ DATE _____
NAME _____
LICENSE NO. 24733/20206 EXPIRATION DATE _____

I HEREBY CERTIFY THAT THE PORTION OF THE SUBMISSION WAS PREPARED BY ME OR UNDER MY DIRECT SUPERVISION AND RESPONSIBLE CHARGE. I AM A DULY REGISTERED ARCHITECT UNDER THE LAWS OF THIS STATE.

ARCHITECTURAL SEAL

I HEREBY CERTIFY THAT THE PORTION OF THE SUBMISSION WAS PREPARED BY ME OR UNDER MY DIRECT SUPERVISION AND RESPONSIBLE CHARGE. I AM A DULY REGISTERED ARCHITECT UNDER THE LAWS OF THIS STATE.

SIGNATURE _____ DATE _____
NAME _____
LICENSE NO. 24733/20206 EXPIRATION DATE _____

I HEREBY CERTIFY THAT THE PORTION OF THE SUBMISSION WAS PREPARED BY ME OR UNDER MY DIRECT SUPERVISION AND RESPONSIBLE CHARGE. I AM A DULY REGISTERED ARCHITECT UNDER THE LAWS OF THIS STATE.

ARCHITECTURAL SEAL

I HEREBY CERTIFY THAT THE PORTION OF THE SUBMISSION WAS PREPARED BY ME OR UNDER MY DIRECT SUPERVISION AND RESPONSIBLE CHARGE. I AM A DULY REGISTERED ARCHITECT UNDER THE LAWS OF THIS STATE.

SIGNATURE _____ DATE _____
NAME _____
LICENSE NO. 24733/20206 EXPIRATION DATE _____

I HEREBY CERTIFY THAT THE PORTION OF THE SUBMISSION WAS PREPARED BY ME OR UNDER MY DIRECT SUPERVISION AND RESPONSIBLE CHARGE. I AM A DULY REGISTERED ARCHITECT UNDER THE LAWS OF THIS STATE.

ARCHITECTURAL SEAL

I HEREBY CERTIFY THAT THE PORTION OF THE SUBMISSION WAS PREPARED BY ME OR UNDER MY DIRECT SUPERVISION AND RESPONSIBLE CHARGE. I AM A DULY REGISTERED ARCHITECT UNDER THE LAWS OF THIS STATE.

SIGNATURE _____ DATE _____
NAME _____
LICENSE NO. 24733/20206 EXPIRATION DATE _____

I HEREBY CERTIFY THAT THE PORTION OF THE SUBMISSION WAS PREPARED BY ME OR UNDER MY DIRECT SUPERVISION AND RESPONSIBLE CHARGE. I AM A DULY REGISTERED ARCHITECT UNDER THE LAWS OF THIS STATE.

ARCHITECTURAL SEAL

I HEREBY CERTIFY THAT THE PORTION OF THE SUBMISSION WAS PREPARED BY ME OR UNDER MY DIRECT SUPERVISION AND RESPONSIBLE CHARGE. I AM A DULY REGISTERED ARCHITECT UNDER THE LAWS OF THIS STATE.

SIGNATURE _____ DATE _____
NAME _____
LICENSE NO. 24733/20206 EXPIRATION DATE _____

I HEREBY CERTIFY THAT THE PORTION OF THE SUBMISSION WAS PREPARED BY ME OR UNDER MY DIRECT SUPERVISION AND RESPONSIBLE CHARGE. I AM A DULY REGISTERED ARCHITECT UNDER THE LAWS OF THIS STATE.

ARCHITECTURAL SEAL

I HEREBY CERTIFY THAT THE PORTION OF THE SUBMISSION WAS PREPARED BY ME OR UNDER MY DIRECT SUPERVISION AND RESPONSIBLE CHARGE. I AM A DULY REGISTERED ARCHITECT UNDER THE LAWS OF THIS STATE.

SIGNATURE _____ DATE _____
NAME _____
LICENSE NO. 24733/20206 EXPIRATION DATE _____

I HEREBY CERTIFY THAT THE PORTION OF THE SUBMISSION WAS PREPARED BY ME OR UNDER MY DIRECT SUPERVISION AND RESPONSIBLE CHARGE. I AM A DULY REGISTERED ARCHITECT UNDER THE LAWS OF THIS STATE.

ARCHITECTURAL SEAL

I HEREBY CERTIFY THAT THE PORTION OF THE SUBMISSION WAS PREPARED BY ME OR UNDER MY DIRECT SUPERVISION AND RESPONSIBLE CHARGE. I AM A DULY REGISTERED ARCHITECT UNDER THE LAWS OF THIS STATE.

SIGNATURE _____ DATE _____
NAME _____
LICENSE NO. 24733/20206 EXPIRATION DATE _____

I HEREBY CERTIFY THAT THE PORTION OF THE SUBMISSION WAS PREPARED BY ME OR UNDER MY DIRECT SUPERVISION AND RESPONSIBLE CHARGE. I AM A DULY REGISTERED ARCHITECT UNDER THE LAWS OF THIS STATE.

ARCHITECTURAL SEAL

I HEREBY CERTIFY THAT THE PORTION OF THE SUBMISSION WAS PREPARED BY ME OR UNDER MY DIRECT SUPERVISION AND RESPONSIBLE CHARGE. I AM A DULY REGISTERED ARCHITECT UNDER THE LAWS OF THIS STATE.

SIGNATURE _____ DATE _____
NAME _____
LICENSE NO. 24733/20206 EXPIRATION DATE _____

I HEREBY CERTIFY THAT THE PORTION OF THE SUBMISSION WAS PREPARED BY ME OR UNDER MY DIRECT SUPERVISION AND RESPONSIBLE CHARGE. I AM A DULY REGISTERED ARCHITECT UNDER THE LAWS OF THIS STATE.

ARCHITECTURAL SEAL

I HEREBY CERTIFY THAT THE PORTION OF THE SUBMISSION WAS PREPARED BY ME OR UNDER MY DIRECT SUPERVISION AND RESPONSIBLE CHARGE. I AM A DULY REGISTERED ARCHITECT UNDER THE LAWS OF THIS STATE.

SIGNATURE _____ DATE _____
NAME _____
LICENSE NO. 24733/20206 EXPIRATION DATE _____

I HEREBY CERTIFY THAT THE PORTION OF THE SUBMISSION WAS PREPARED BY ME OR UNDER MY DIRECT SUPERVISION AND RESPONSIBLE CHARGE. I AM A DULY REGISTERED ARCHITECT UNDER THE LAWS OF THIS STATE.

ARCHITECTURAL SEAL

I HEREBY CERTIFY THAT THE PORTION OF THE SUBMISSION WAS PREPARED BY ME OR UNDER MY DIRECT SUPERVISION AND RESPONSIBLE CHARGE. I AM A DULY REGISTERED ARCHITECT UNDER THE LAWS OF THIS STATE.

SIGNATURE _____ DATE _____
NAME _____
LICENSE NO. 24733/20206 EXPIRATION DATE _____

I HEREBY CERTIFY THAT THE PORTION OF THE SUBMISSION WAS PREPARED BY ME OR UNDER MY DIRECT SUPERVISION AND RESPONSIBLE CHARGE. I AM A DULY REGISTERED ARCHITECT UNDER THE LAWS OF THIS STATE.

ARCHITECTURAL SEAL

I HEREBY CERTIFY THAT THE PORTION OF THE SUBMISSION WAS PREPARED BY ME OR UNDER MY DIRECT SUPERVISION AND RESPONSIBLE CHARGE. I AM A DULY REGISTERED ARCHITECT UNDER THE LAWS OF THIS STATE.

SIGNATURE _____ DATE _____
NAME _____
LICENSE NO. 24733/20206 EXPIRATION DATE _____

I HEREBY CERTIFY THAT THE PORTION OF THE SUBMISSION WAS PREPARED BY ME OR UNDER MY DIRECT SUPERVISION AND RESPONSIBLE CHARGE. I AM A DULY REGISTERED ARCHITECT UNDER THE LAWS OF THIS STATE.

ARCHITECTURAL SEAL

I HEREBY CERTIFY THAT THE PORTION OF THE SUBMISSION WAS PREPARED BY ME OR UNDER MY DIRECT SUPERVISION AND RESPONSIBLE CHARGE. I AM A DULY REGISTERED ARCHITECT UNDER THE LAWS OF THIS STATE.

SIGNATURE _____ DATE _____
NAME _____
LICENSE NO. 24733/20206 EXPIRATION DATE _____

I HEREBY CERTIFY THAT THE PORTION OF THE SUBMISSION WAS PREPARED BY ME OR UNDER MY DIRECT SUPERVISION AND RESPONSIBLE CHARGE. I AM A DULY REGISTERED ARCHITECT UNDER THE LAWS OF THIS STATE.

ARCHITECTURAL SEAL

I HEREBY CERTIFY THAT THE PORTION OF THE SUBMISSION WAS PREPARED BY ME OR UNDER MY DIRECT SUPERVISION AND RESPONSIBLE CHARGE. I AM A DULY REGISTERED ARCHITECT UNDER THE LAWS OF THIS STATE.

SIGNATURE _____ DATE _____
NAME _____
LICENSE NO. 24733/20206 EXPIRATION DATE _____

I HEREBY CERTIFY THAT THE PORTION OF THE SUBMISSION WAS PREPARED BY ME OR UNDER MY DIRECT SUPERVISION AND RESPONSIBLE CHARGE. I AM A DULY REGISTERED ARCHITECT UNDER THE LAWS OF THIS STATE.

ARCHITECTURAL SEAL

I HEREBY CERTIFY THAT THE PORTION OF THE SUBMISSION WAS PREPARED BY ME OR UNDER MY DIRECT SUPERVISION AND RESPONSIBLE CHARGE. I AM A DULY REGISTERED ARCHITECT UNDER THE LAWS OF THIS STATE.

SIGNATURE _____ DATE _____
NAME _____
LICENSE NO. 24733/20206 EXPIRATION DATE _____

I HEREBY CERTIFY THAT THE PORTION OF THE SUBMISSION WAS PREPARED BY ME OR UNDER MY DIRECT SUPERVISION AND RESPONSIBLE CHARGE. I AM A DULY REGISTERED ARCHITECT UNDER THE LAWS OF THIS STATE.

ARCHITECTURAL SEAL

I HEREBY CERTIFY THAT THE PORTION OF THE SUBMISSION WAS PREPARED BY ME OR UNDER MY DIRECT SUPERVISION AND RESPONSIBLE CHARGE. I AM A DULY REGISTERED ARCHITECT UNDER THE LAWS OF THIS STATE.

SIGNATURE _____ DATE _____
NAME _____
LICENSE NO. 24733/20206 EXPIRATION DATE _____

I HEREBY CERTIFY THAT THE PORTION OF THE SUBMISSION WAS PREPARED BY ME OR UNDER MY DIRECT SUPERVISION AND RESPONSIBLE CHARGE. I AM A DULY REGISTERED ARCHITECT UNDER THE LAWS OF THIS STATE.

ARCHITECTURAL SEAL

I HEREBY CERTIFY THAT THE PORTION OF THE SUBMISSION WAS PREPARED BY ME OR UNDER MY DIRECT SUPERVISION AND RESPONSIBLE CHARGE. I AM A DULY REGISTERED ARCHITECT UNDER THE LAWS OF THIS STATE.

SIGNATURE _____ DATE _____
NAME _____
LICENSE NO. 24733/20206 EXPIRATION DATE _____

I HEREBY CERTIFY THAT THE PORTION OF THE SUBMISSION WAS PREPARED BY ME OR UNDER MY DIRECT SUPERVISION AND RESPONSIBLE CHARGE. I AM A DULY REGISTERED ARCHITECT UNDER THE LAWS OF THIS STATE.

ARCHITECTURAL SEAL

I HEREBY CERTIFY THAT THE PORTION OF THE SUBMISSION WAS PREPARED BY ME OR UNDER MY DIRECT SUPERVISION AND RESPONSIBLE CHARGE. I AM A DULY REGISTERED ARCHITECT UNDER THE LAWS OF THIS STATE.

SIGNATURE _____ DATE _____
NAME _____
LICENSE NO. 24733/20206 EXPIRATION DATE _____

I HEREBY CERTIFY THAT THE PORTION OF THE SUBMISSION WAS PREPARED BY ME OR UNDER MY DIRECT SUPERVISION AND RESPONSIBLE CHARGE. I AM A DULY REGISTERED ARCHITECT UNDER THE LAWS OF THIS STATE.

ARCHITECTURAL SEAL

I HEREBY CERTIFY THAT THE PORTION OF THE SUBMISSION WAS PREPARED BY ME OR UNDER MY DIRECT SUPERVISION AND RESPONSIBLE CHARGE. I AM A DULY REGISTERED ARCHITECT UNDER THE LAWS OF THIS STATE.

SIGNATURE _____ DATE _____
NAME _____
LICENSE NO. 24733/20206 EXPIRATION DATE _____

I HEREBY CERTIFY THAT THE PORTION OF THE SUBMISSION WAS PREPARED BY ME OR UNDER MY DIRECT SUPERVISION AND RESPONSIBLE CHARGE. I AM A DULY REGISTERED ARCHITECT UNDER THE LAWS OF THIS STATE.

ARCHITECTURAL SEAL

I HEREBY CERTIFY THAT THE PORTION OF THE SUBMISSION WAS PREPARED BY ME OR UNDER MY DIRECT SUPERVISION AND RESPONSIBLE CHARGE. I AM A DULY REGISTERED ARCHITECT UNDER THE LAWS OF THIS STATE.

SIGNATURE _____ DATE _____
NAME _____
LICENSE NO. 24733/20206 EXPIRATION DATE _____

I HEREBY CERTIFY THAT THE PORTION OF THE SUBMISSION WAS PREPARED BY ME OR UNDER MY DIRECT SUPERVISION AND RESPONSIBLE CHARGE. I AM A DULY REGISTERED ARCHITECT UNDER THE LAWS OF THIS STATE.

ARCHITECTURAL SEAL

I HEREBY CERTIFY THAT THE PORTION OF THE SUBMISSION WAS PREPARED BY ME OR UNDER MY DIRECT SUPERVISION AND RESPONSIBLE CHARGE. I AM A DULY REGISTERED ARCHITECT UNDER THE LAWS OF THIS STATE.

SIGNATURE _____ DATE _____
NAME _____
LICENSE NO. 24733/20206 EXPIRATION DATE _____

I HEREBY CERTIFY THAT THE PORTION OF THE SUBMISSION WAS PREPARED BY ME OR UNDER MY DIRECT SUPERVISION AND RESPONSIBLE CHARGE. I AM A DULY REGISTERED ARCHITECT UNDER THE LAWS OF THIS STATE.

ARCHITECTURAL SEAL

I HEREBY CERTIFY THAT THE PORTION OF THE SUBMISSION WAS PREPARED BY ME OR UNDER MY DIRECT SUPERVISION AND RESPONSIBLE CHARGE. I AM A DULY REGISTERED ARCHITECT UNDER THE LAWS OF THIS STATE.

SIGNATURE _____ DATE _____
NAME _____
LICENSE NO. 24733/20206 EXPIRATION DATE _____

I HEREBY CERTIFY THAT THE PORTION OF THE SUBMISSION WAS PREPARED BY ME OR UNDER MY DIRECT SUPERVISION AND RESPONSIBLE CHARGE. I AM A DULY REGISTERED ARCHITECT UNDER THE LAWS OF THIS STATE.

ARCHITECTURAL SEAL

I HEREBY CERTIFY THAT THE PORTION OF THE SUBMISSION WAS PREPARED BY ME OR UNDER MY DIRECT SUPERVISION AND RESPONSIBLE CHARGE. I AM A DULY REGISTERED ARCHITECT UNDER THE LAWS OF THIS STATE.

SIGNATURE _____ DATE _____
NAME _____
LICENSE NO. 24733/20206 EXPIRATION DATE _____

I HEREBY CERTIFY THAT THE PORTION OF THE SUBMISSION WAS PREPARED BY ME OR UNDER MY DIRECT SUPERVISION AND RESPONSIBLE CHARGE. I AM A DULY REGISTERED ARCHITECT UNDER THE LAWS OF THIS STATE.

ARCHITECTURAL SEAL


I HEREBY CERTIFY THAT THE PORTION OF THE SUBMISSION WAS PREPARED BY ME OR UNDER MY DIRECT SUPERVISION AND RESPONSIBLE CHARGE. I AM A DULY REGISTERED ARCHITECT UNDER THE LAWS OF THIS STATE.

SIGNATURE _____ DATE _____
NAME _____
LICENSE NO. 24733/20206 EXPIRATION DATE _____

I HEREBY CERTIFY THAT THE PORTION OF THE SUBMISSION WAS PREPARED BY ME OR UNDER MY DIRECT SUPERVISION AND RESPONSIBLE CHARGE. I AM A DULY REGISTERED ARCHITECT UNDER THE LAWS OF THIS STATE.

<

C:\Users\YanB\OneDrive - Geis Companies\Desktop\JM Addition\LD_JM_A-100_FLOOR PLAN.dwg 07/19/2026 Ryan Bertrand 20:00


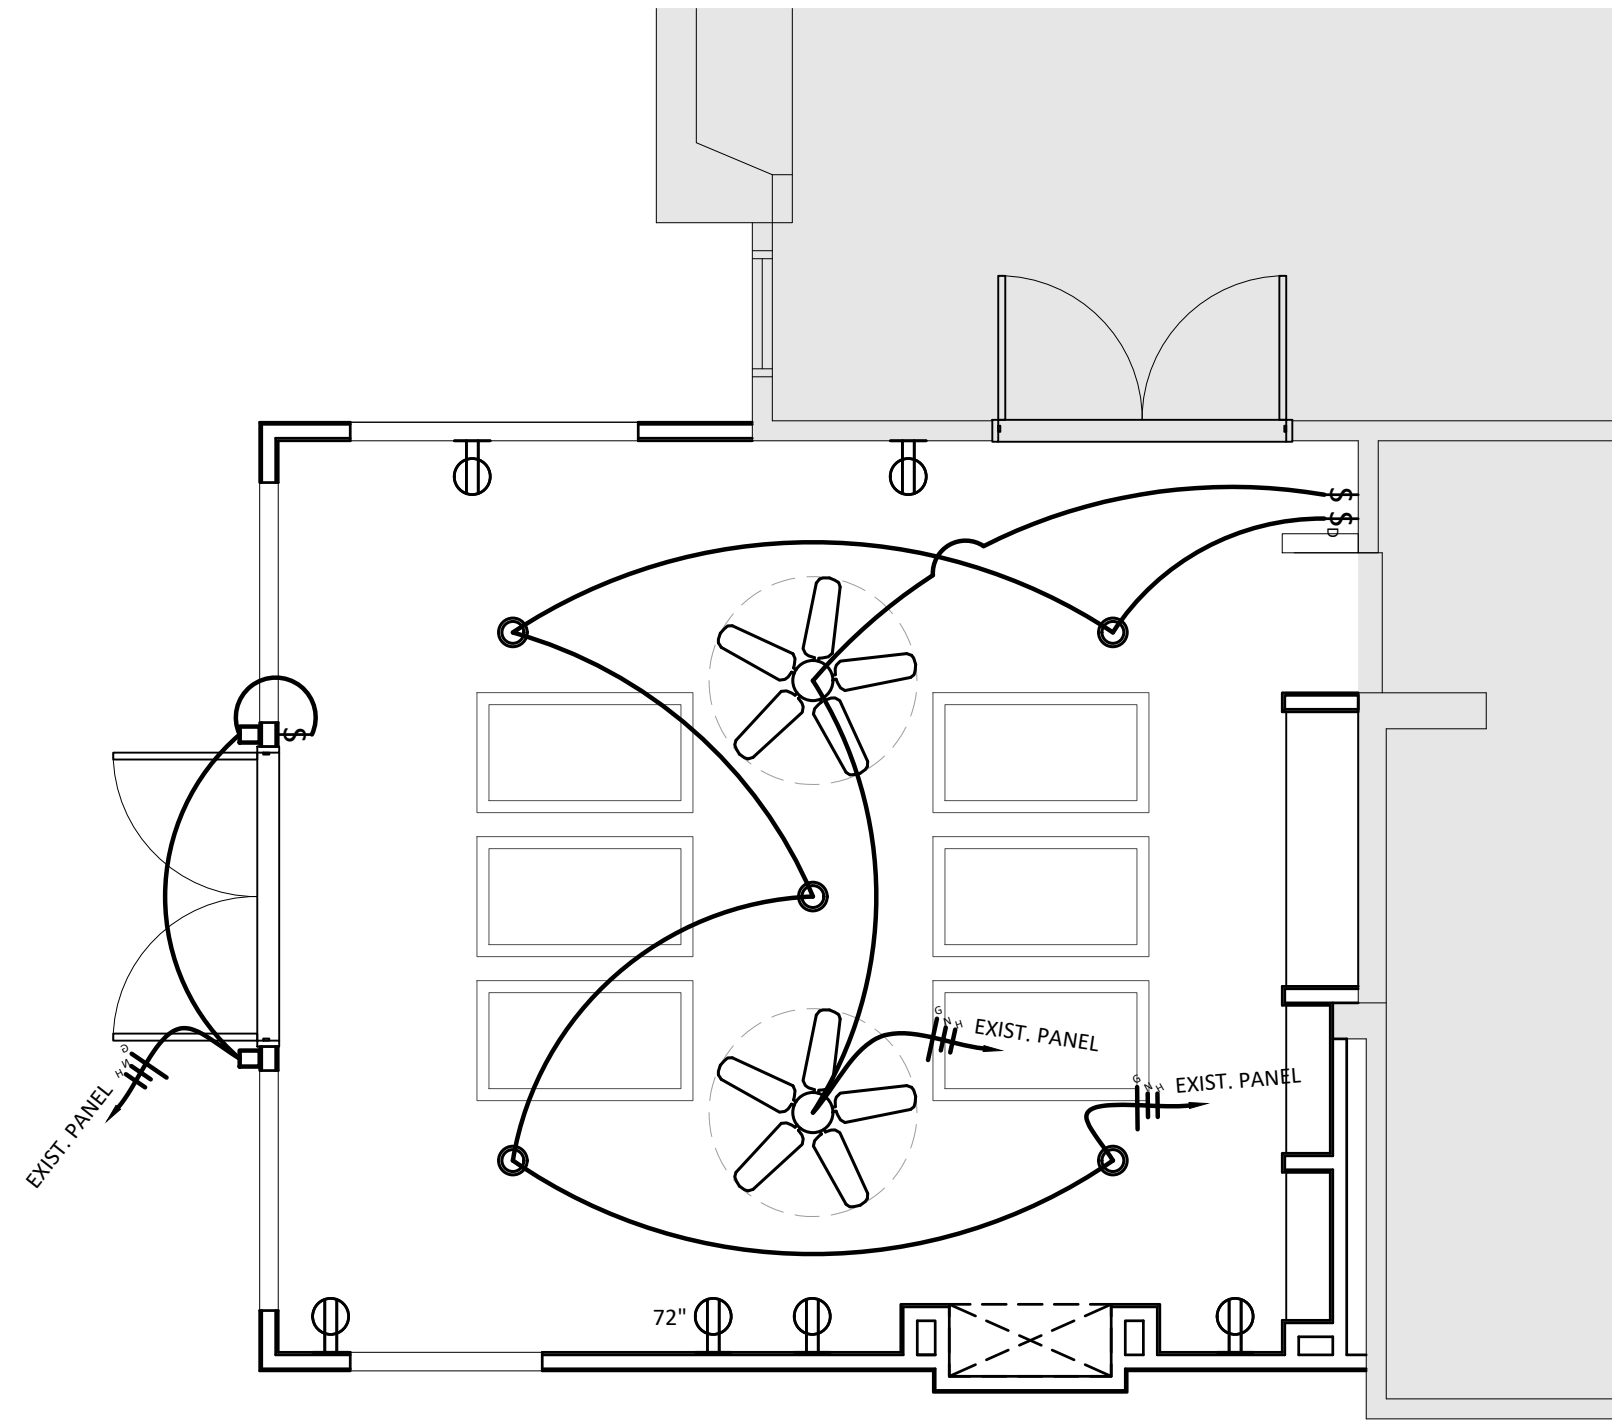


- NOTES:
1. CONFIRM RECEPTACLE AND SWITCH LOCATION WITH OWNER PRIOR TO INSTALL
 2. CIRCUIT ALL NEW FIXTURES & RECEPTACLES TO EXISTING PANEL
 3. CIRCUIT INTERNALLY POWERED BLINDS ON SKYLIGHTS TO EXISTING PANEL

ENLARGED ELECTRICAL PLAN

SCALE: 1/4" = 1'-0"



5
A-100

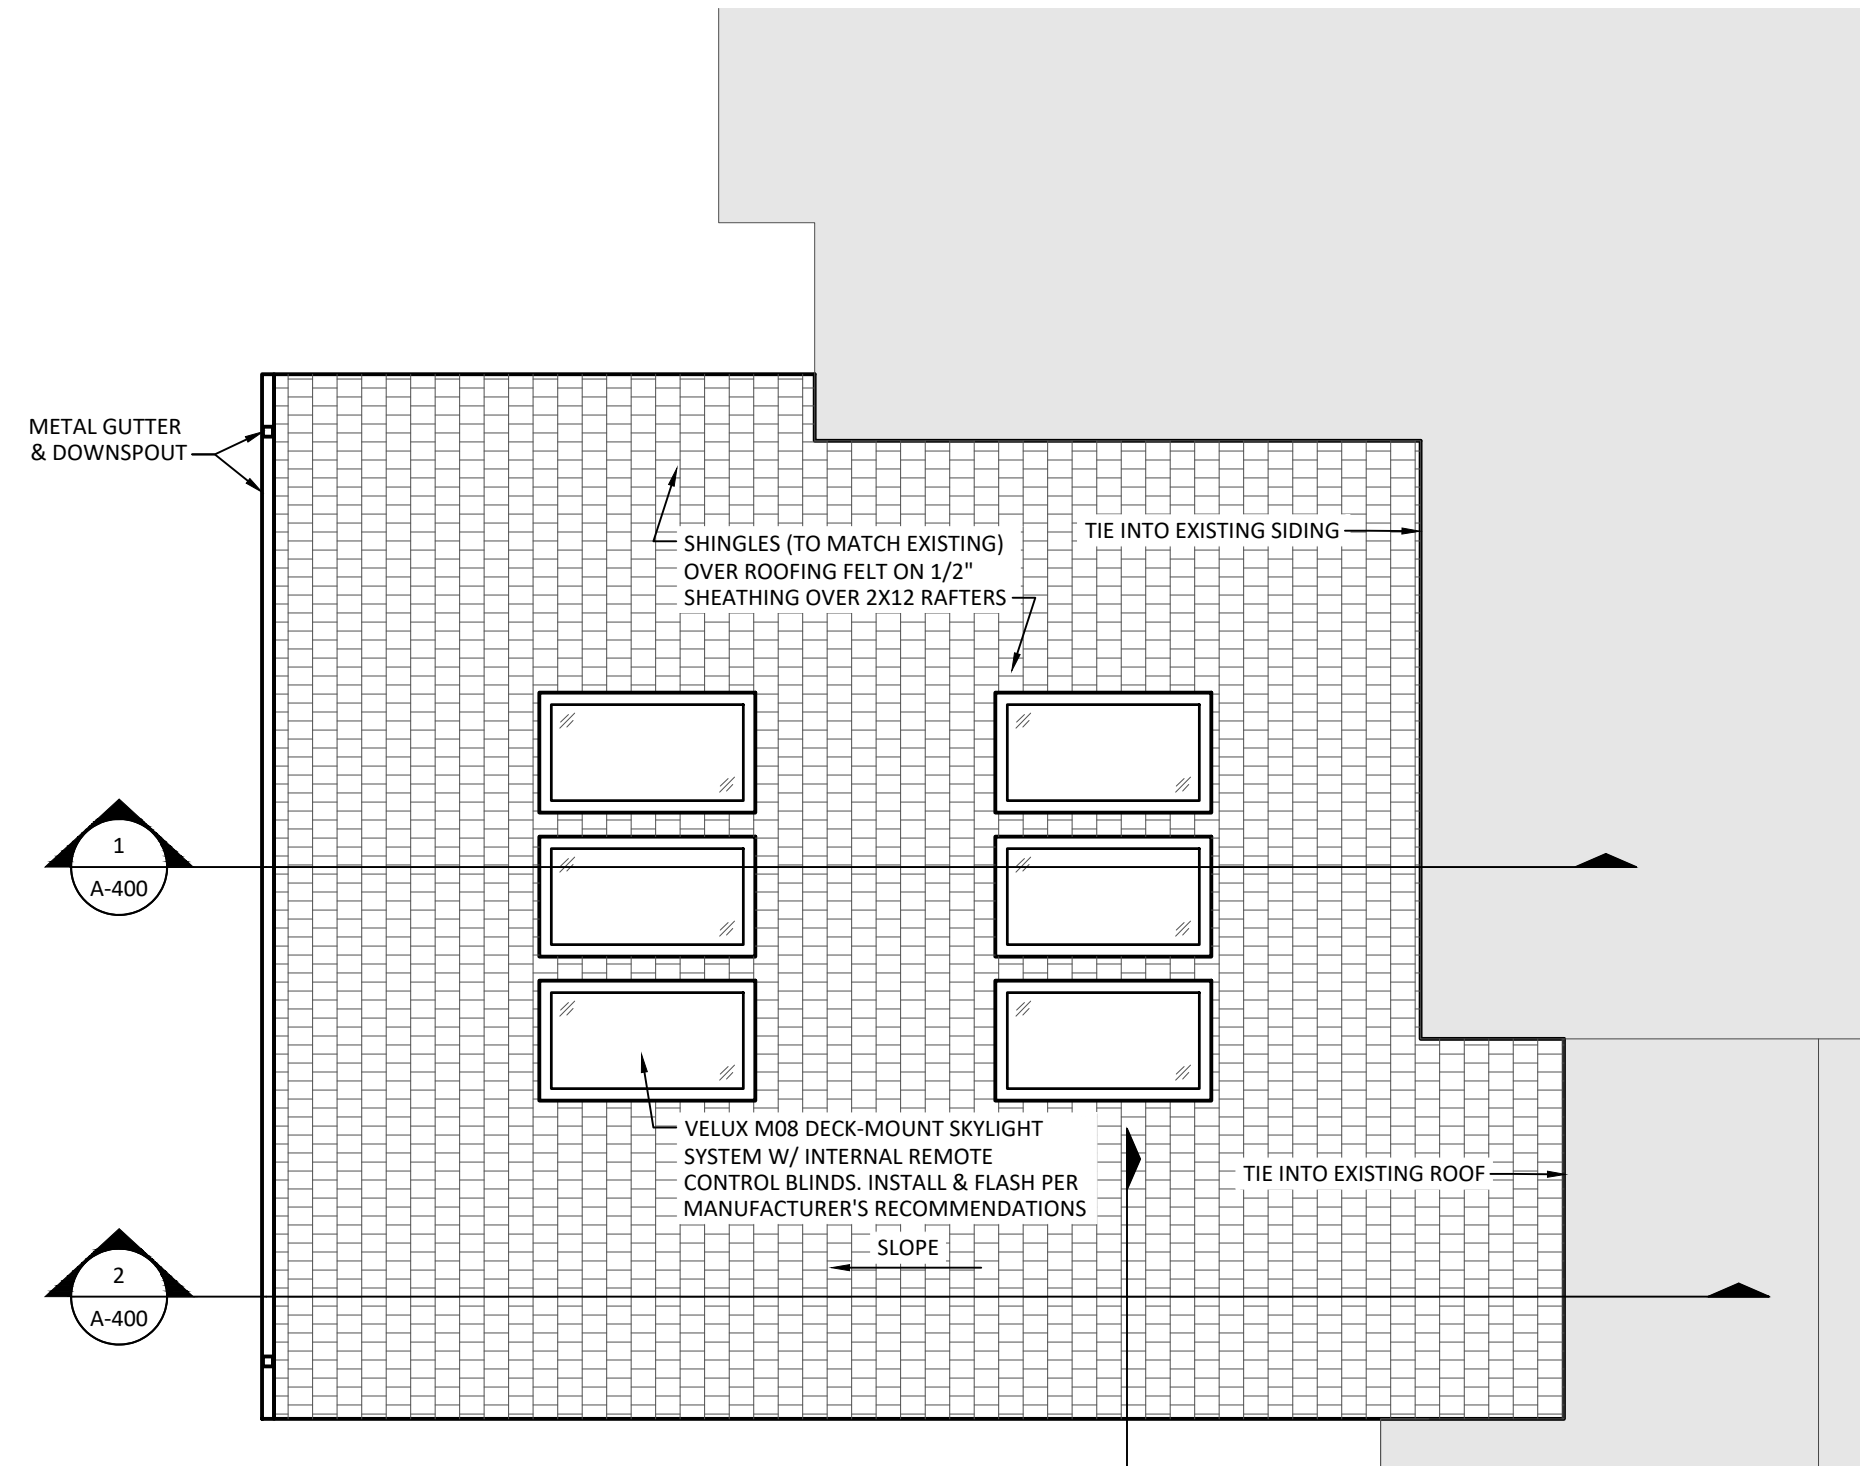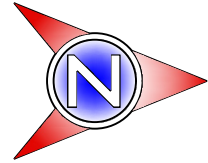

ENLARGED ROOF PLAN

SCALE: 1/4" = 1'-0"


4
A-100

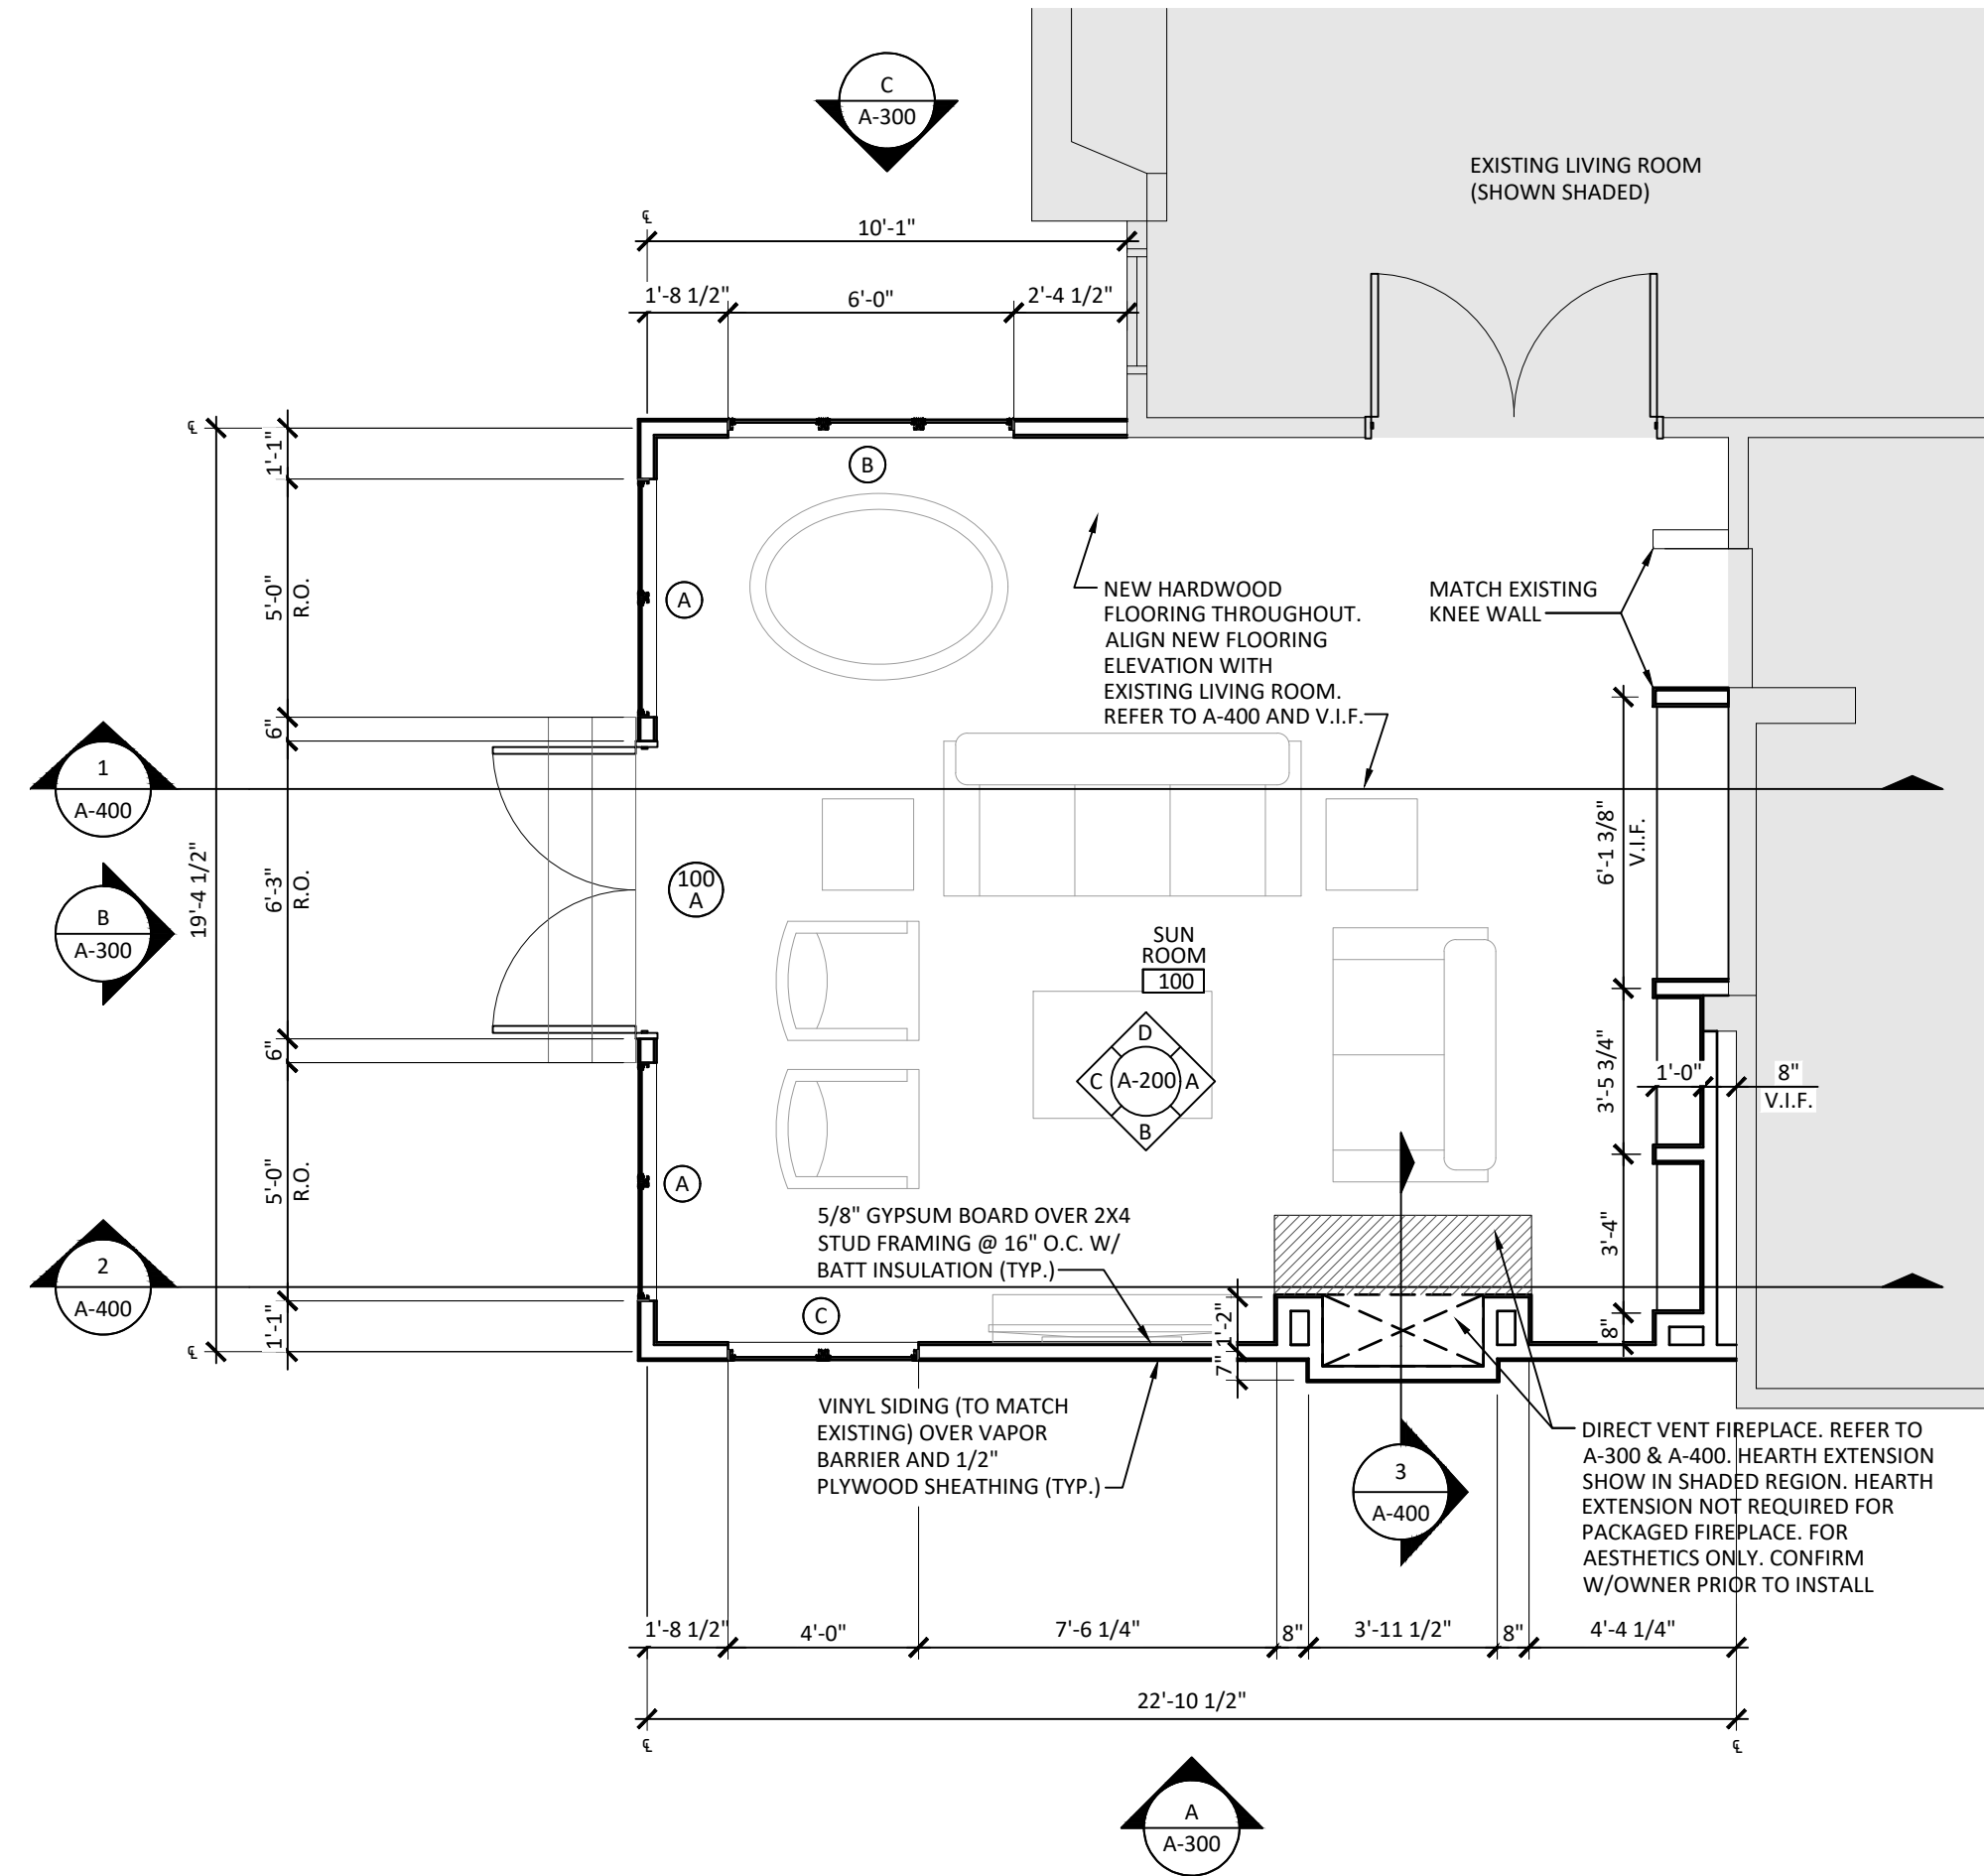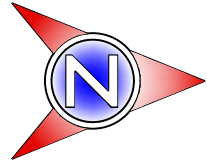

ENLARGED FLOOR PLAN


SCALE: 1/4" = 1'-0"

2
A-100

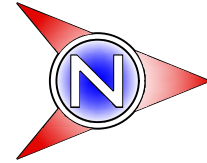


DOOR SCHEDULE								TRIM				NOTES
NO.	DOOR SIZE	DOOR		FRAME		DOOR GLASS	HINGES	RAIN Drip	THRESHOLD	GASKET		
		MATERIAL	FINISH	THROAT WIDTH	MATERIAL							
100	A	(2) 3'-0" X 7'-0"	1	1	4 5/8"	1	X	6	X	X	X	1, 2

DOOR SCHEDULE NOTES	
#	DESCRIPTION
1.	MATCH EXISTING DOOR MATERIAL & FINISH
2.	PELLA HINGED PATIO DOOR OR APPROVED EQUAL (APPROVE W/ OWNER)

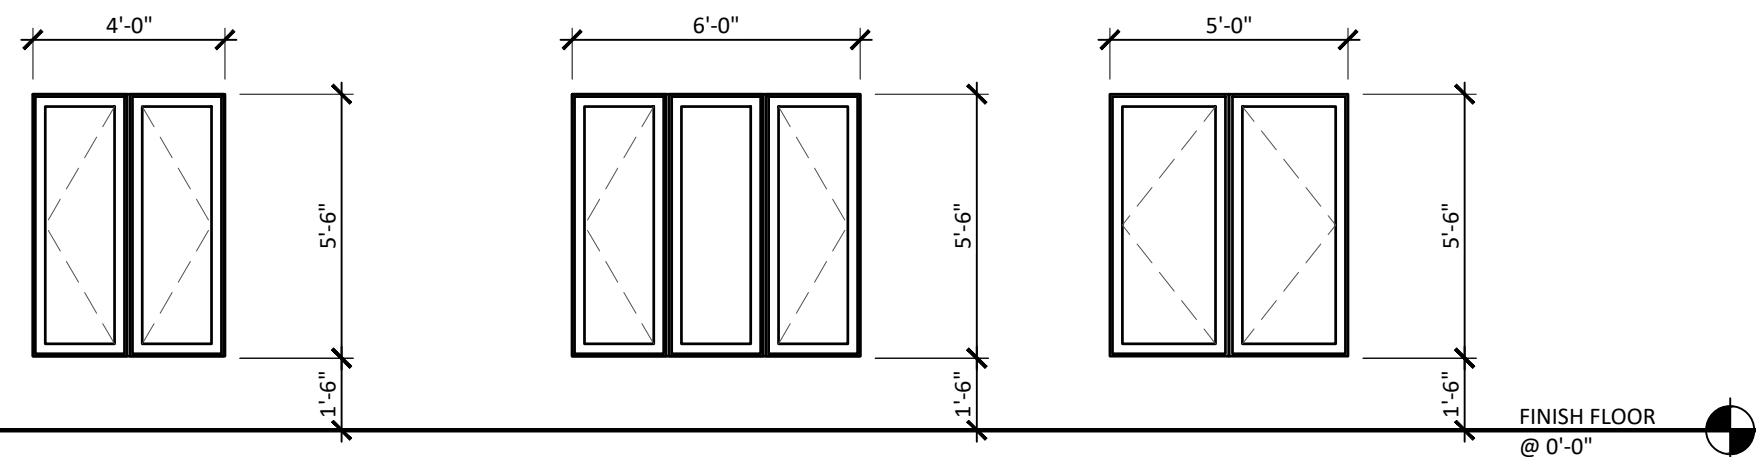

EXTERIOR GLAZING ELEVATIONS



SCALE: 1/4" = 1'-0"

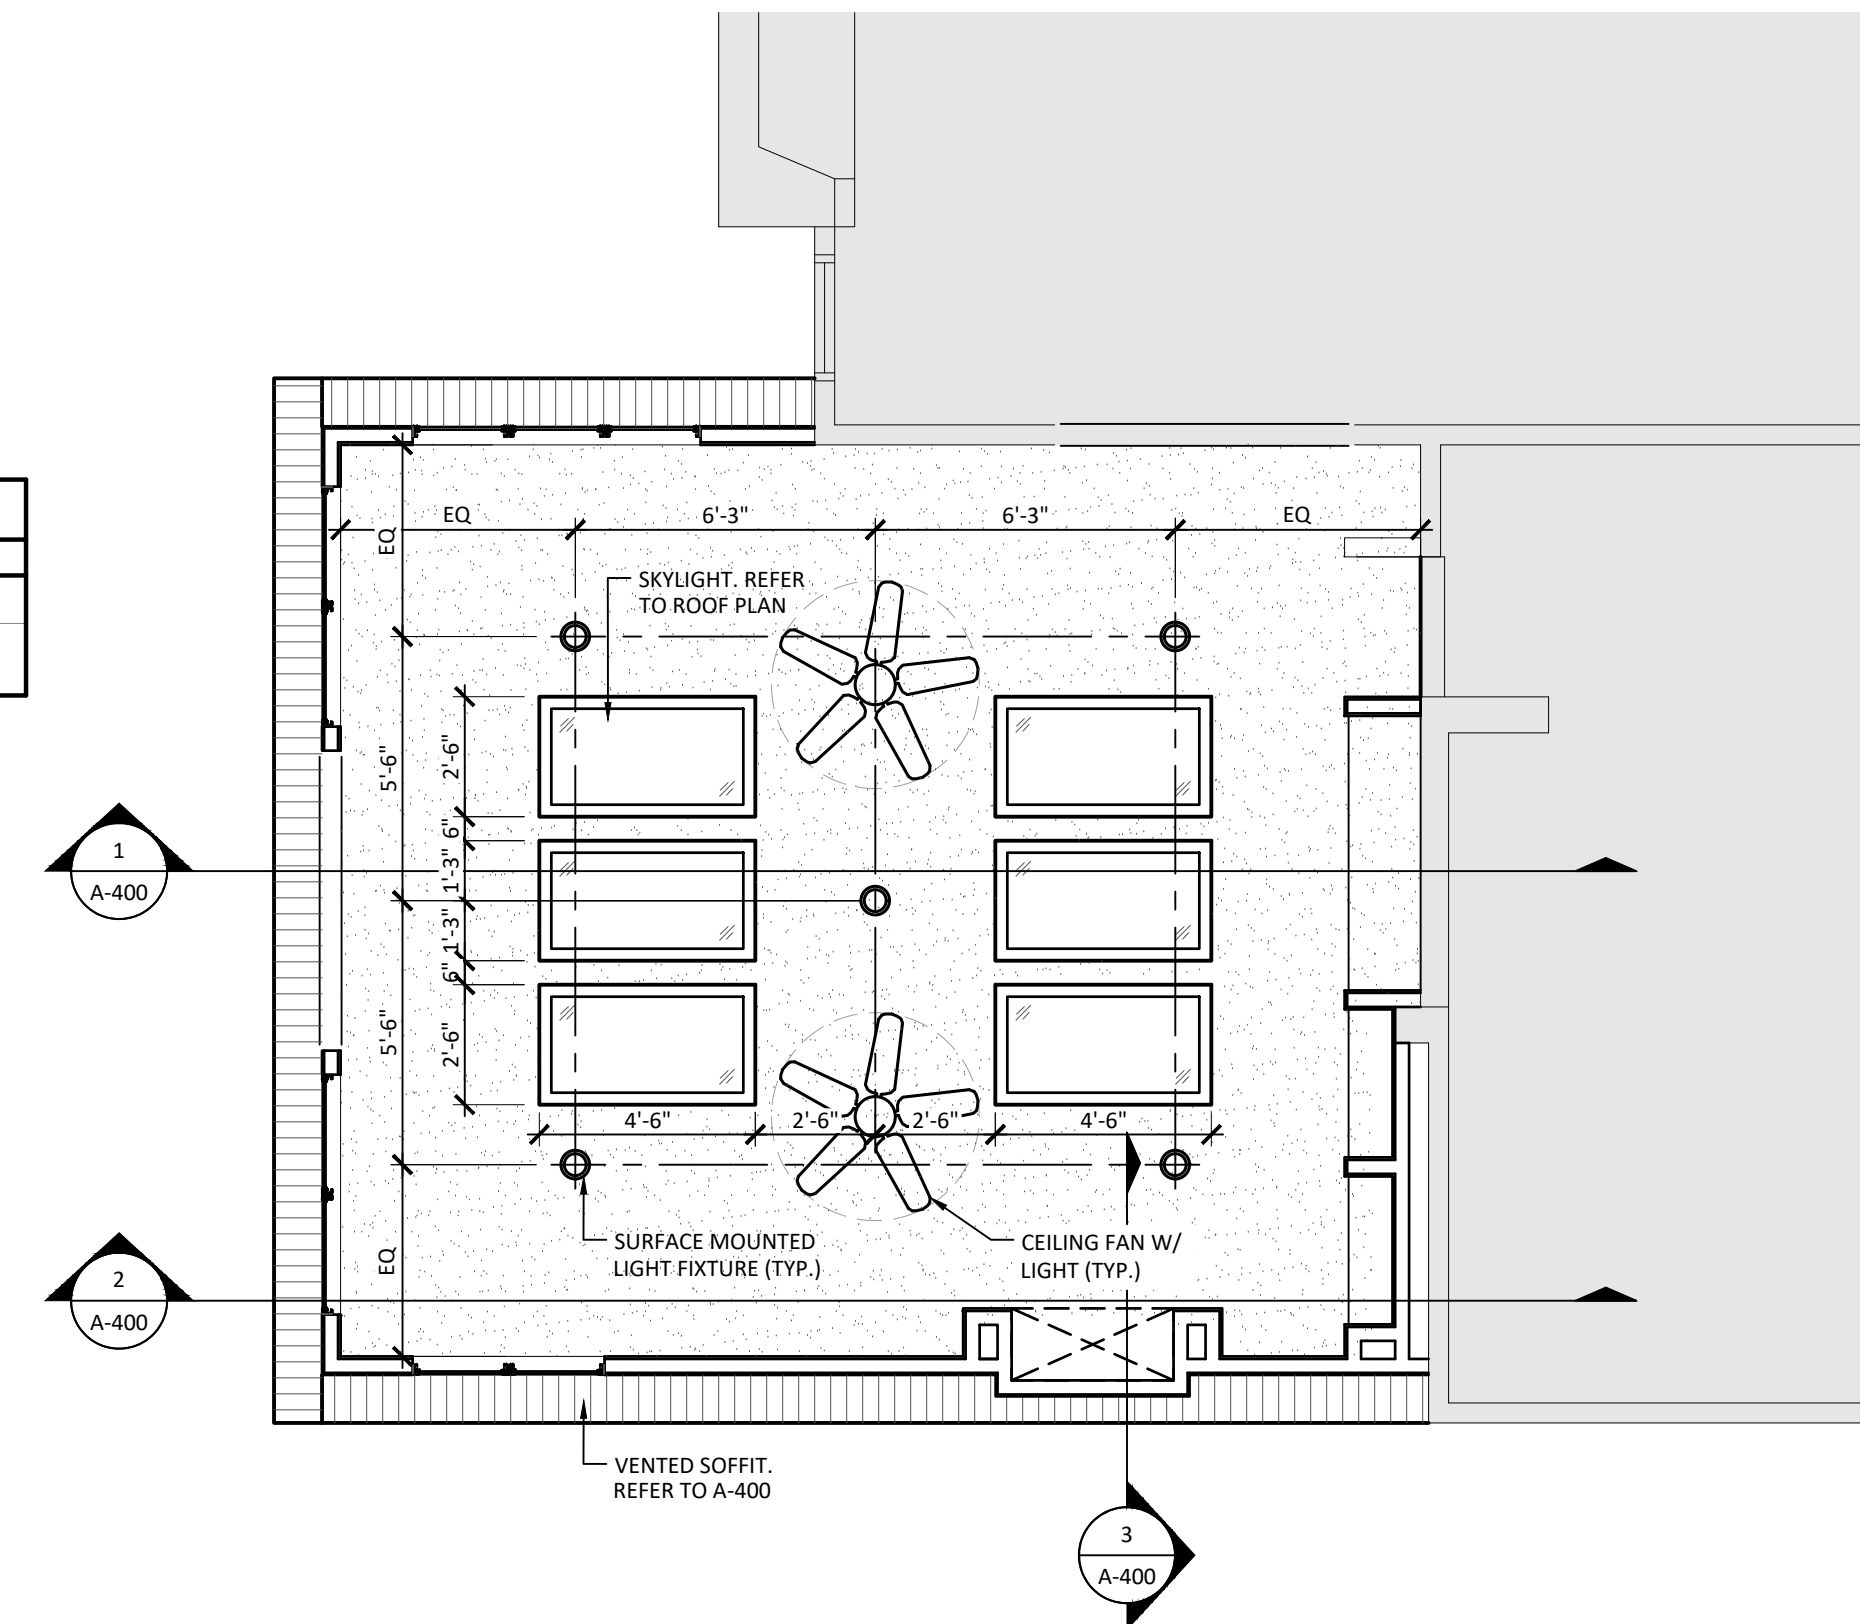

ENLARGED CEILING PLAN

SCALE: 1/4" = 1'-0"


3
A-100

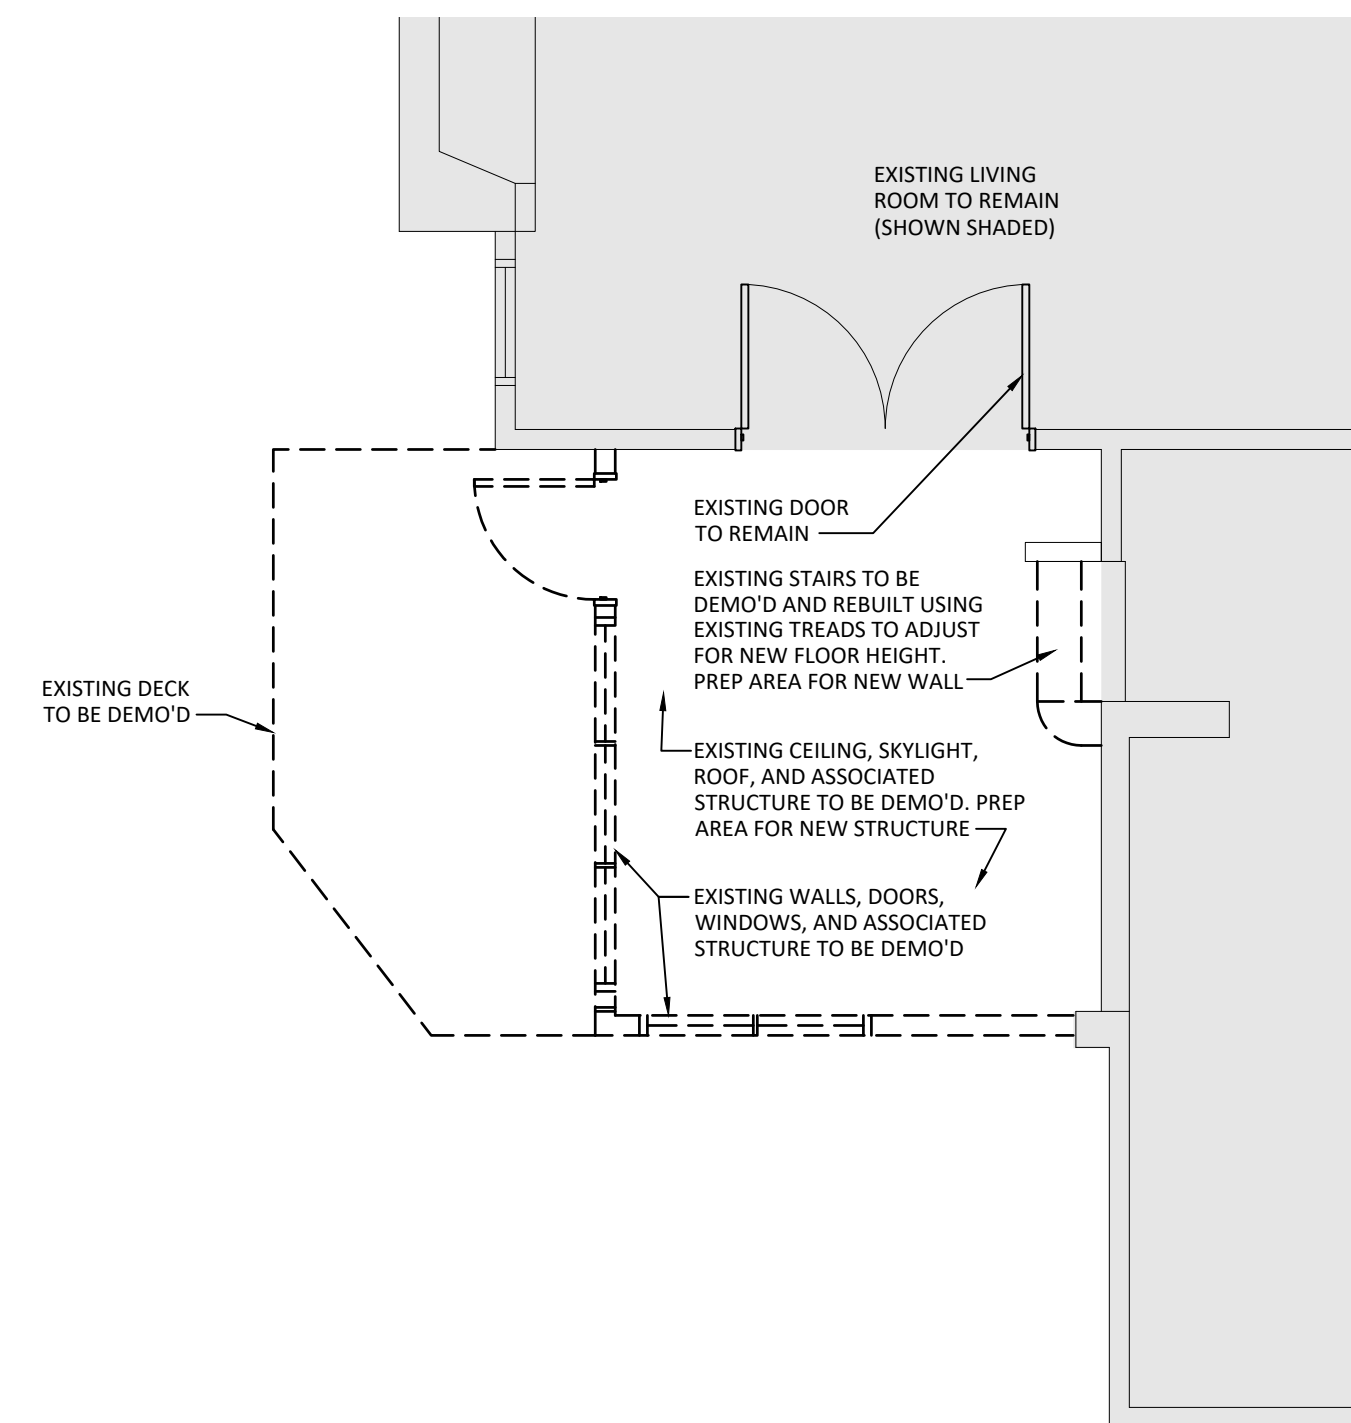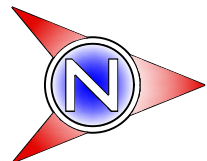

ENLARGED DEMO PLAN

SCALE: 1/4" = 1'-0"

1
A-100

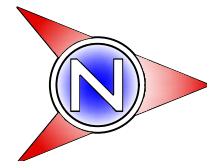

PRELIMINARY
NOT FOR CONSTRUCTION

GDOT DESIGN

10020 Aurora-Hudson Rd
Streetsboro, Ohio 44241
PH: (330) 528-3500
FX: (330) 528-0008
www.geiscompanies.com

Drawn By: ----
Checked By: ----
Project Number: ###-###-####

NOTICE

THIS ARCHITECTURAL AND ENGINEERING DRAWING IS GIVEN IN CONFIDENCE. NO USE OR DISSEMINATION MAY BE MADE WITHOUT PRIOR WRITTEN CONSENT OF THE ARCHITECT. ALL RIGHTS ARE HEREBY SPECIFICALLY RESERVED. GEIS CONSTRUCTION

REVISIONS REFLECTED IN THESE DRAWINGS INVOLVE CHANGES TO CONTRACT PRICE PREVIOUSLY PROVIDED. CHANGE ORDERS WILL BE PROVIDED FOR ALL CHANGES. THESE CHANGES ARE NOT IN THE BASE BID.

DATES AND REVISIONS

01-03-2026
PROGRESS SET



GEIS COMPANIES

10020 Aurora-Hudson Rd
Streetsboro, Ohio 44241
PH: (330) 528-3500
FX: (330) 528-0008
www.geiscompanies.com

JM ADDITION
2880 BLAILEY DRIVE
HUDSON, OHIO 44236

OVERALL
FLOOR PLANS

A-100

 GDOT DESIGN
10020 Aurora-Hudson Rd
Streetsboro, Ohio 44241
PH: (330) 528-3500
FX: (330) 528-0008
www.geiscompanies.com

NOTICE

THIS ARCHITECTURAL AND
ENGINEERING DRAWING IS GIVEN IN
CONFIDENCE. NO USE OR
DISSEMINATION MAY BE MADE
WITHOUT PRIOR WRITTEN CONSENT
OF THE ARCHITECT. ALL RIGHTS ARE
HEREBY SPECIFICALLY RESERVED.
GEIS CONSTRUCTION

REVISIONS REFLECTED IN THESE
DRAWINGS INVOLVE CHANGES TO
CONTRACT PRICE PREVIOUSLY
PROVIDED. CHANGE ORDERS WILL BE
PROVIDED FOR ALL CHANGES. THESE
CHANGES ARE NOT IN THE BASE BID.

[illegible]

A-200



PRELIMINARY
NOT FOR CONSTRUCTION

GDOT DESIGN
10020 Aurora-Hudson Rd
Streetsboro, Ohio 44241
PH: (330) 528-3500
FX: (330) 528-0008
www.geiscompanies.com

Drawn By: ----
Checked By: ----
Project Number: ###-###-####

NOTICE
THIS ARCHITECTURAL AND ENGINEERING DRAWING IS GIVEN IN CONFIDENCE. NO USE OR DISSEMINATION MAY BE MADE WITHOUT PRIOR WRITTEN CONSENT OF THE ARCHITECT. ALL RIGHTS ARE HEREBY SPECIFICALLY RESERVED. GEIS CONSTRUCTION
REVISIONS REFLECTED IN THESE DRAWINGS INVOLVE CHANGES TO CONTRACT PRICE PREVIOUSLY PROVIDED. CHANGE ORDERS WILL BE PROVIDED FOR ALL CHANGES. THESE CHANGES ARE NOT IN THE BASE BID.


DATES AND REVISIONS
01-03-2026
PROGRESS SET

GEIS COMPANIES
10020 Aurora-Hudson Rd
Streetsboro, Ohio 44241
PH: (330) 528-3500
FX: (330) 528-0008
www.geiscompanies.com

JM ADDITION
2880 BLAIKLEY DRIVE
HUDSON, OHIO 44236


BUILDING
SECTIONS

A-400

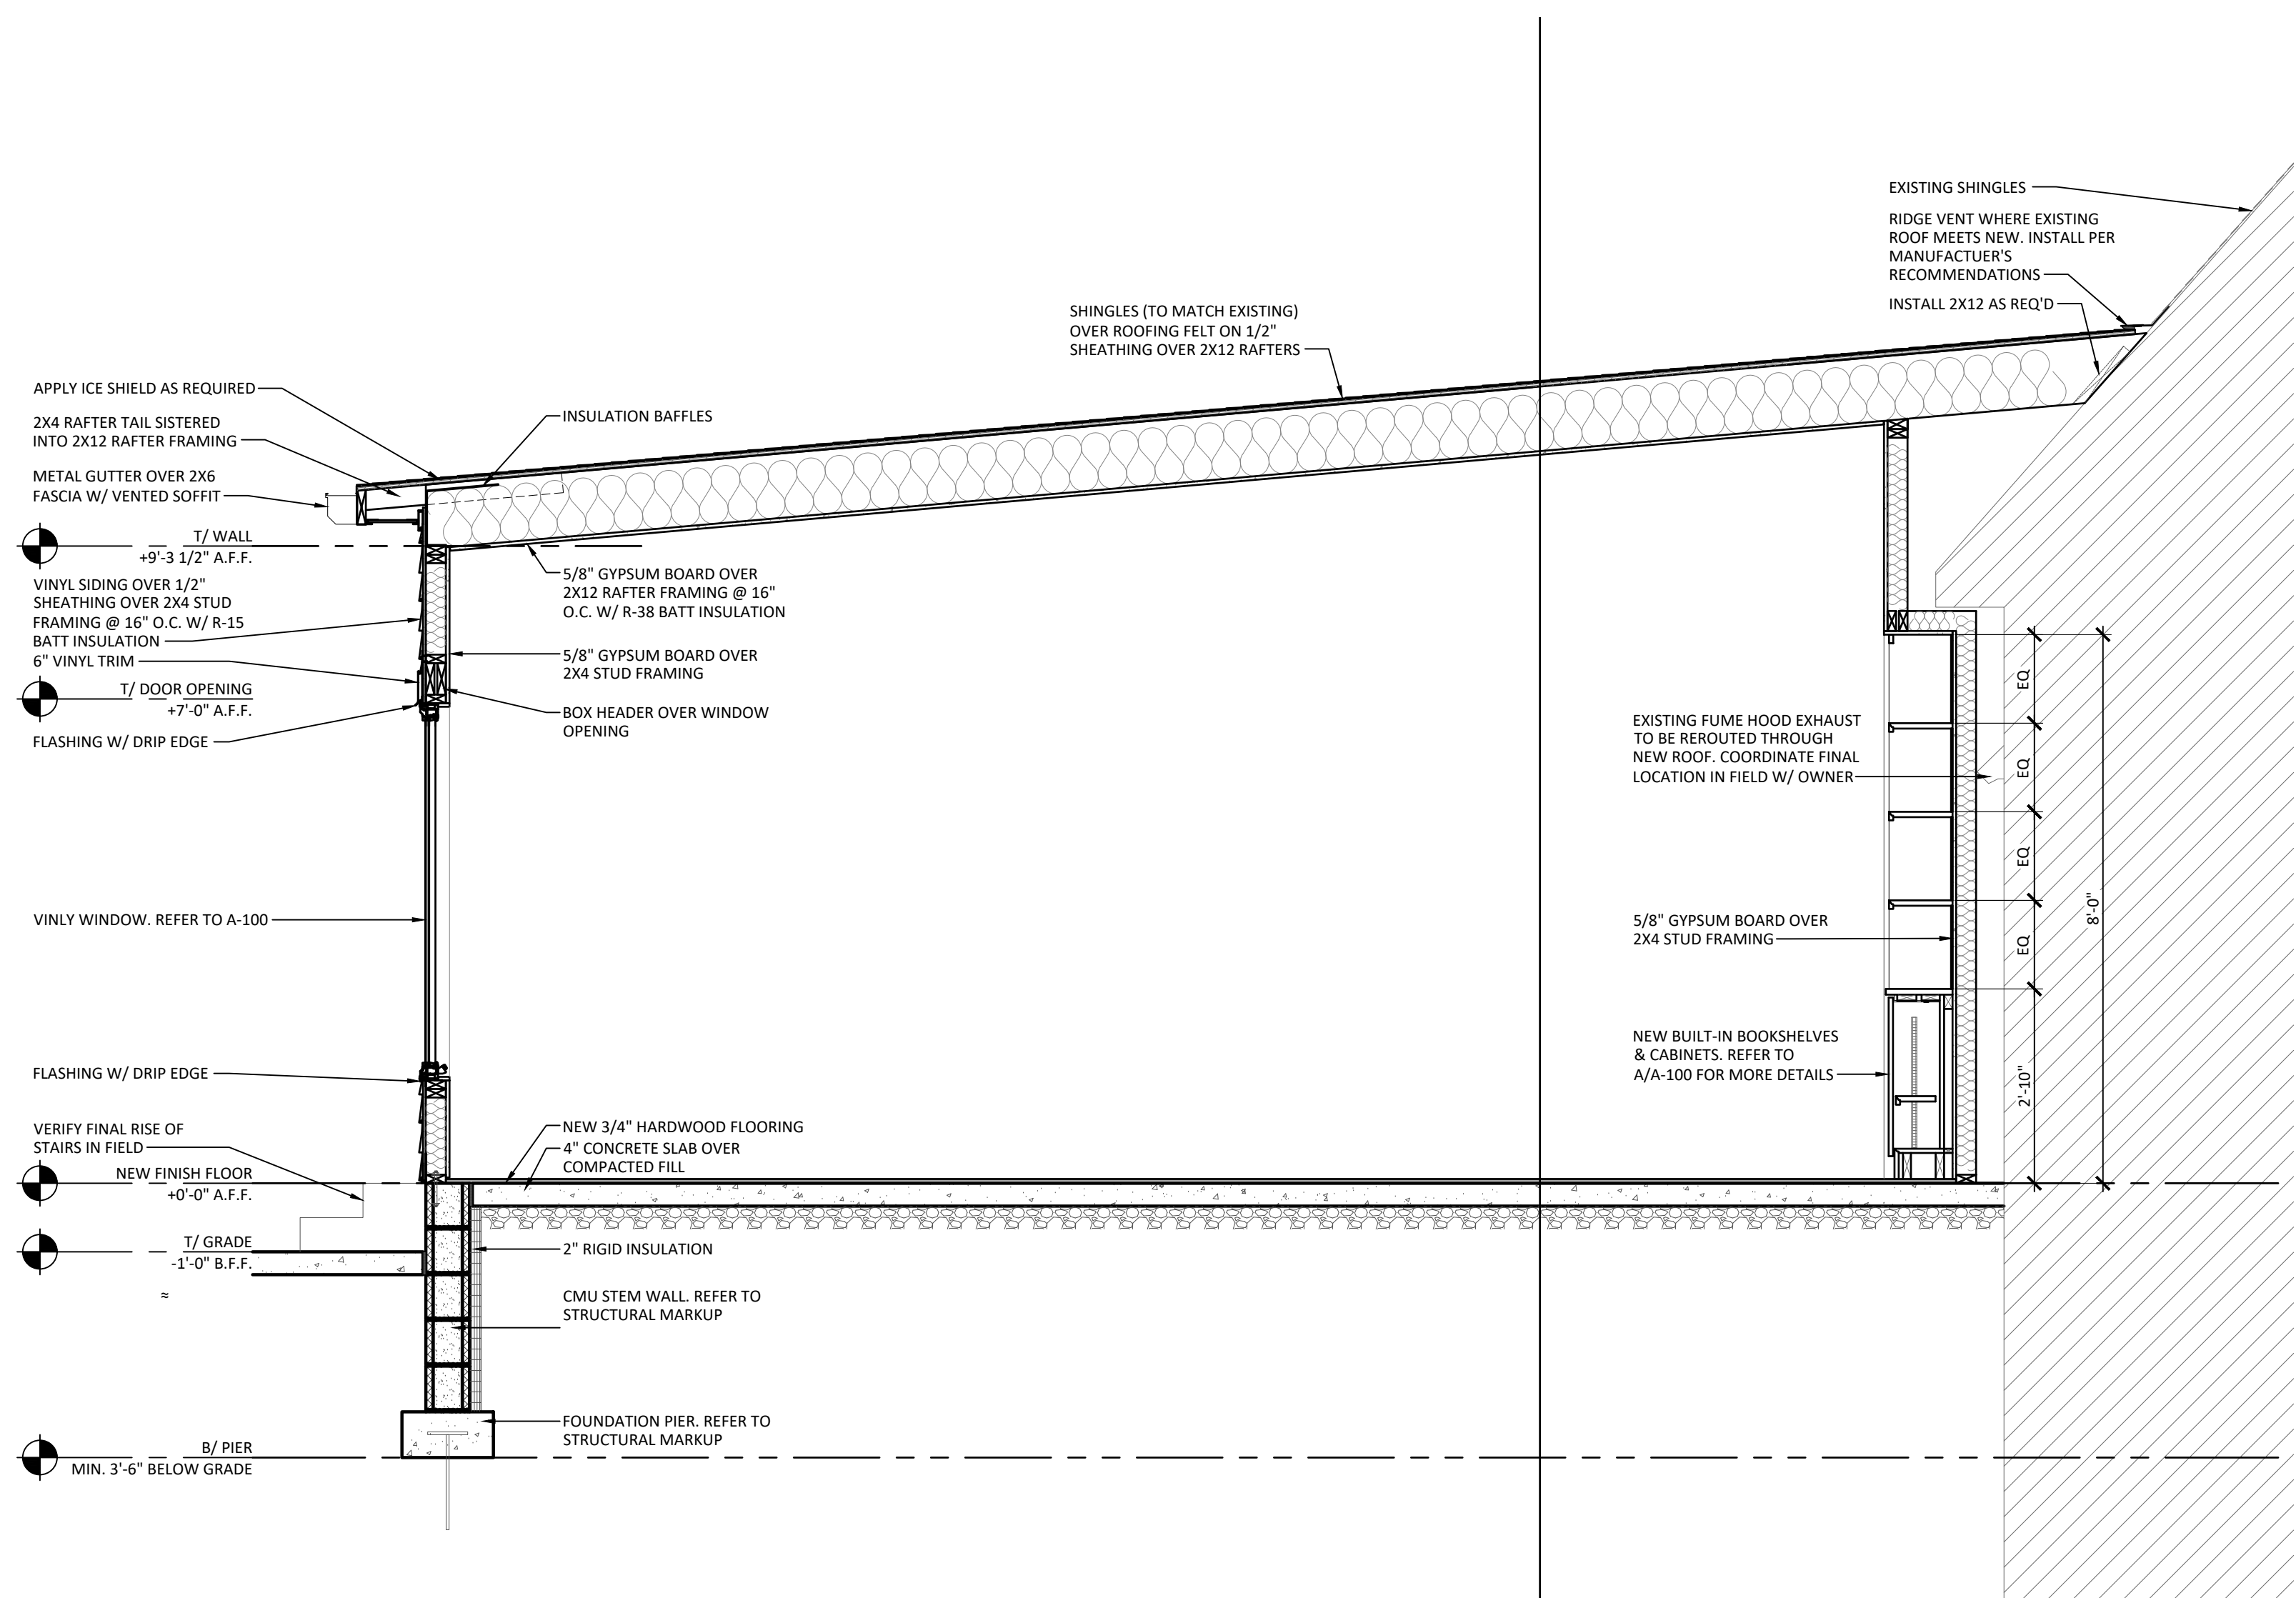


BUILDING SECTION
SCALE: 1/2" = 1'-0"

2
A-400

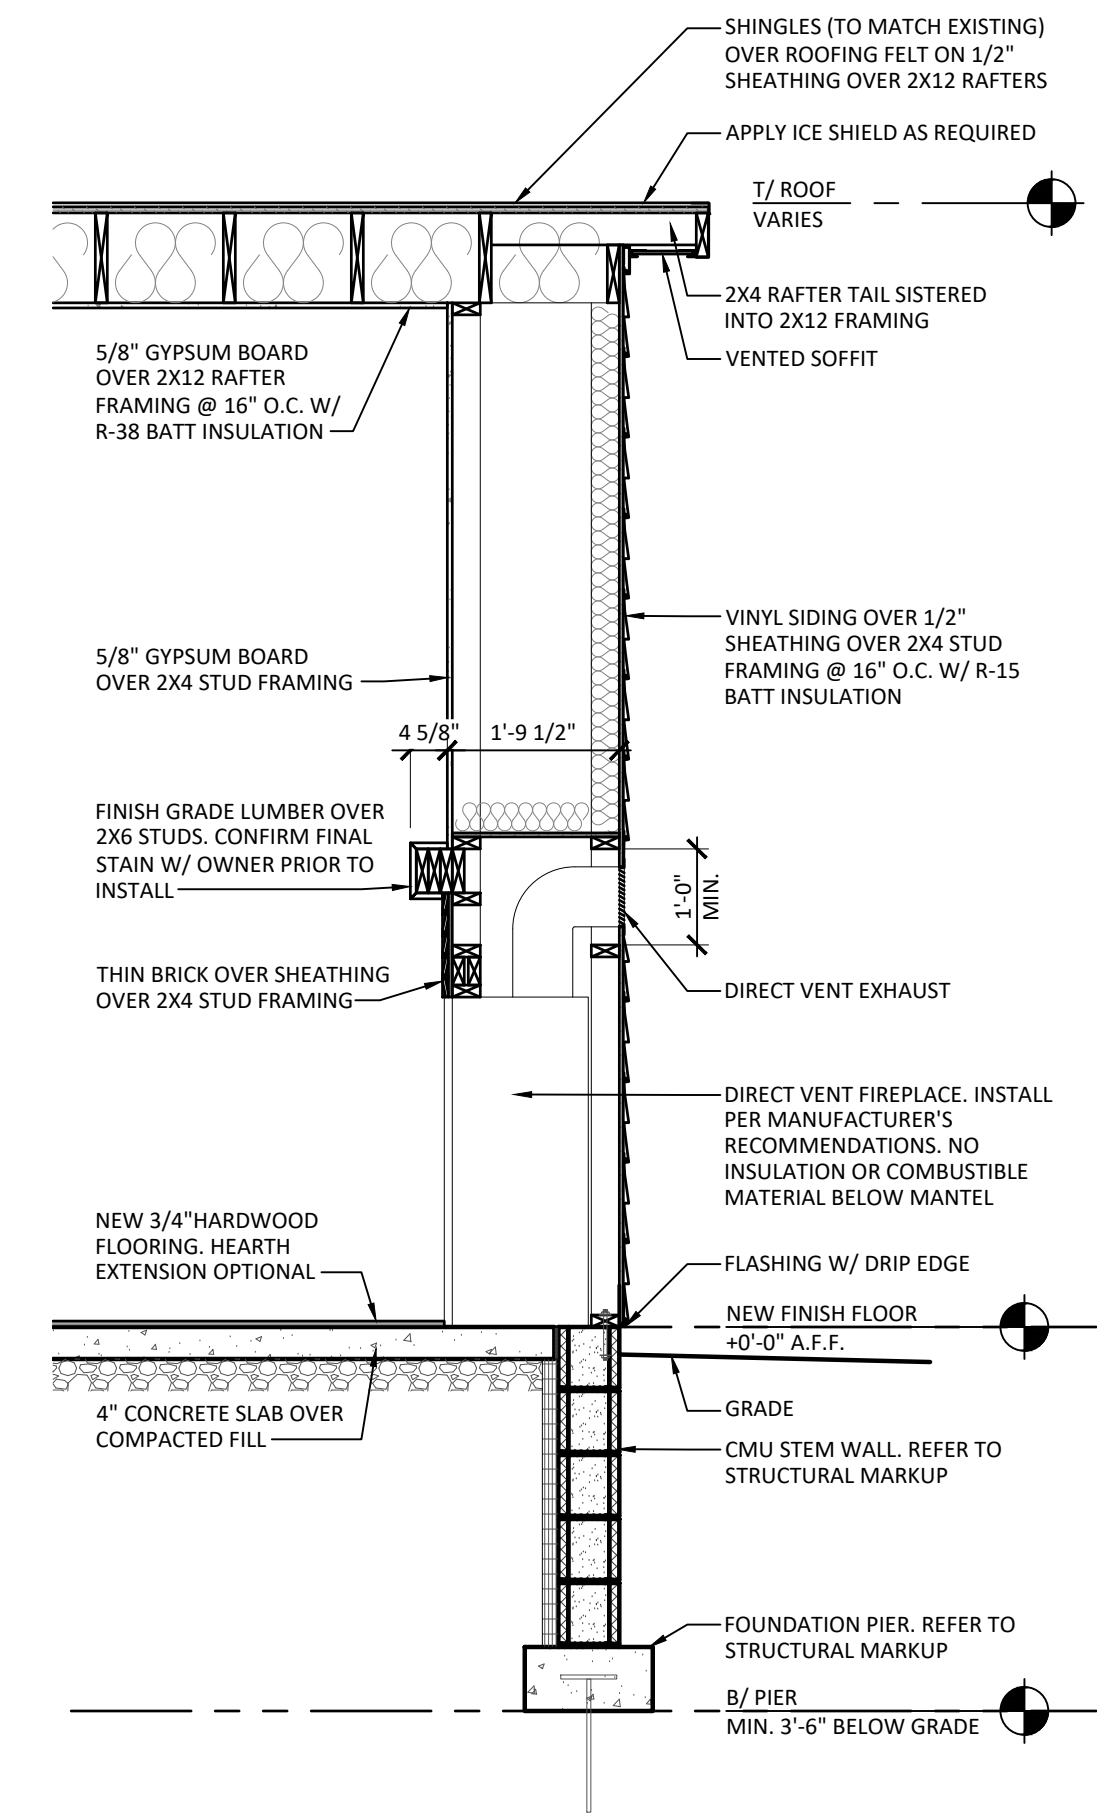

CHIMNEY SECTION
SCALE: 1/2" = 1'-0"

3
A-400

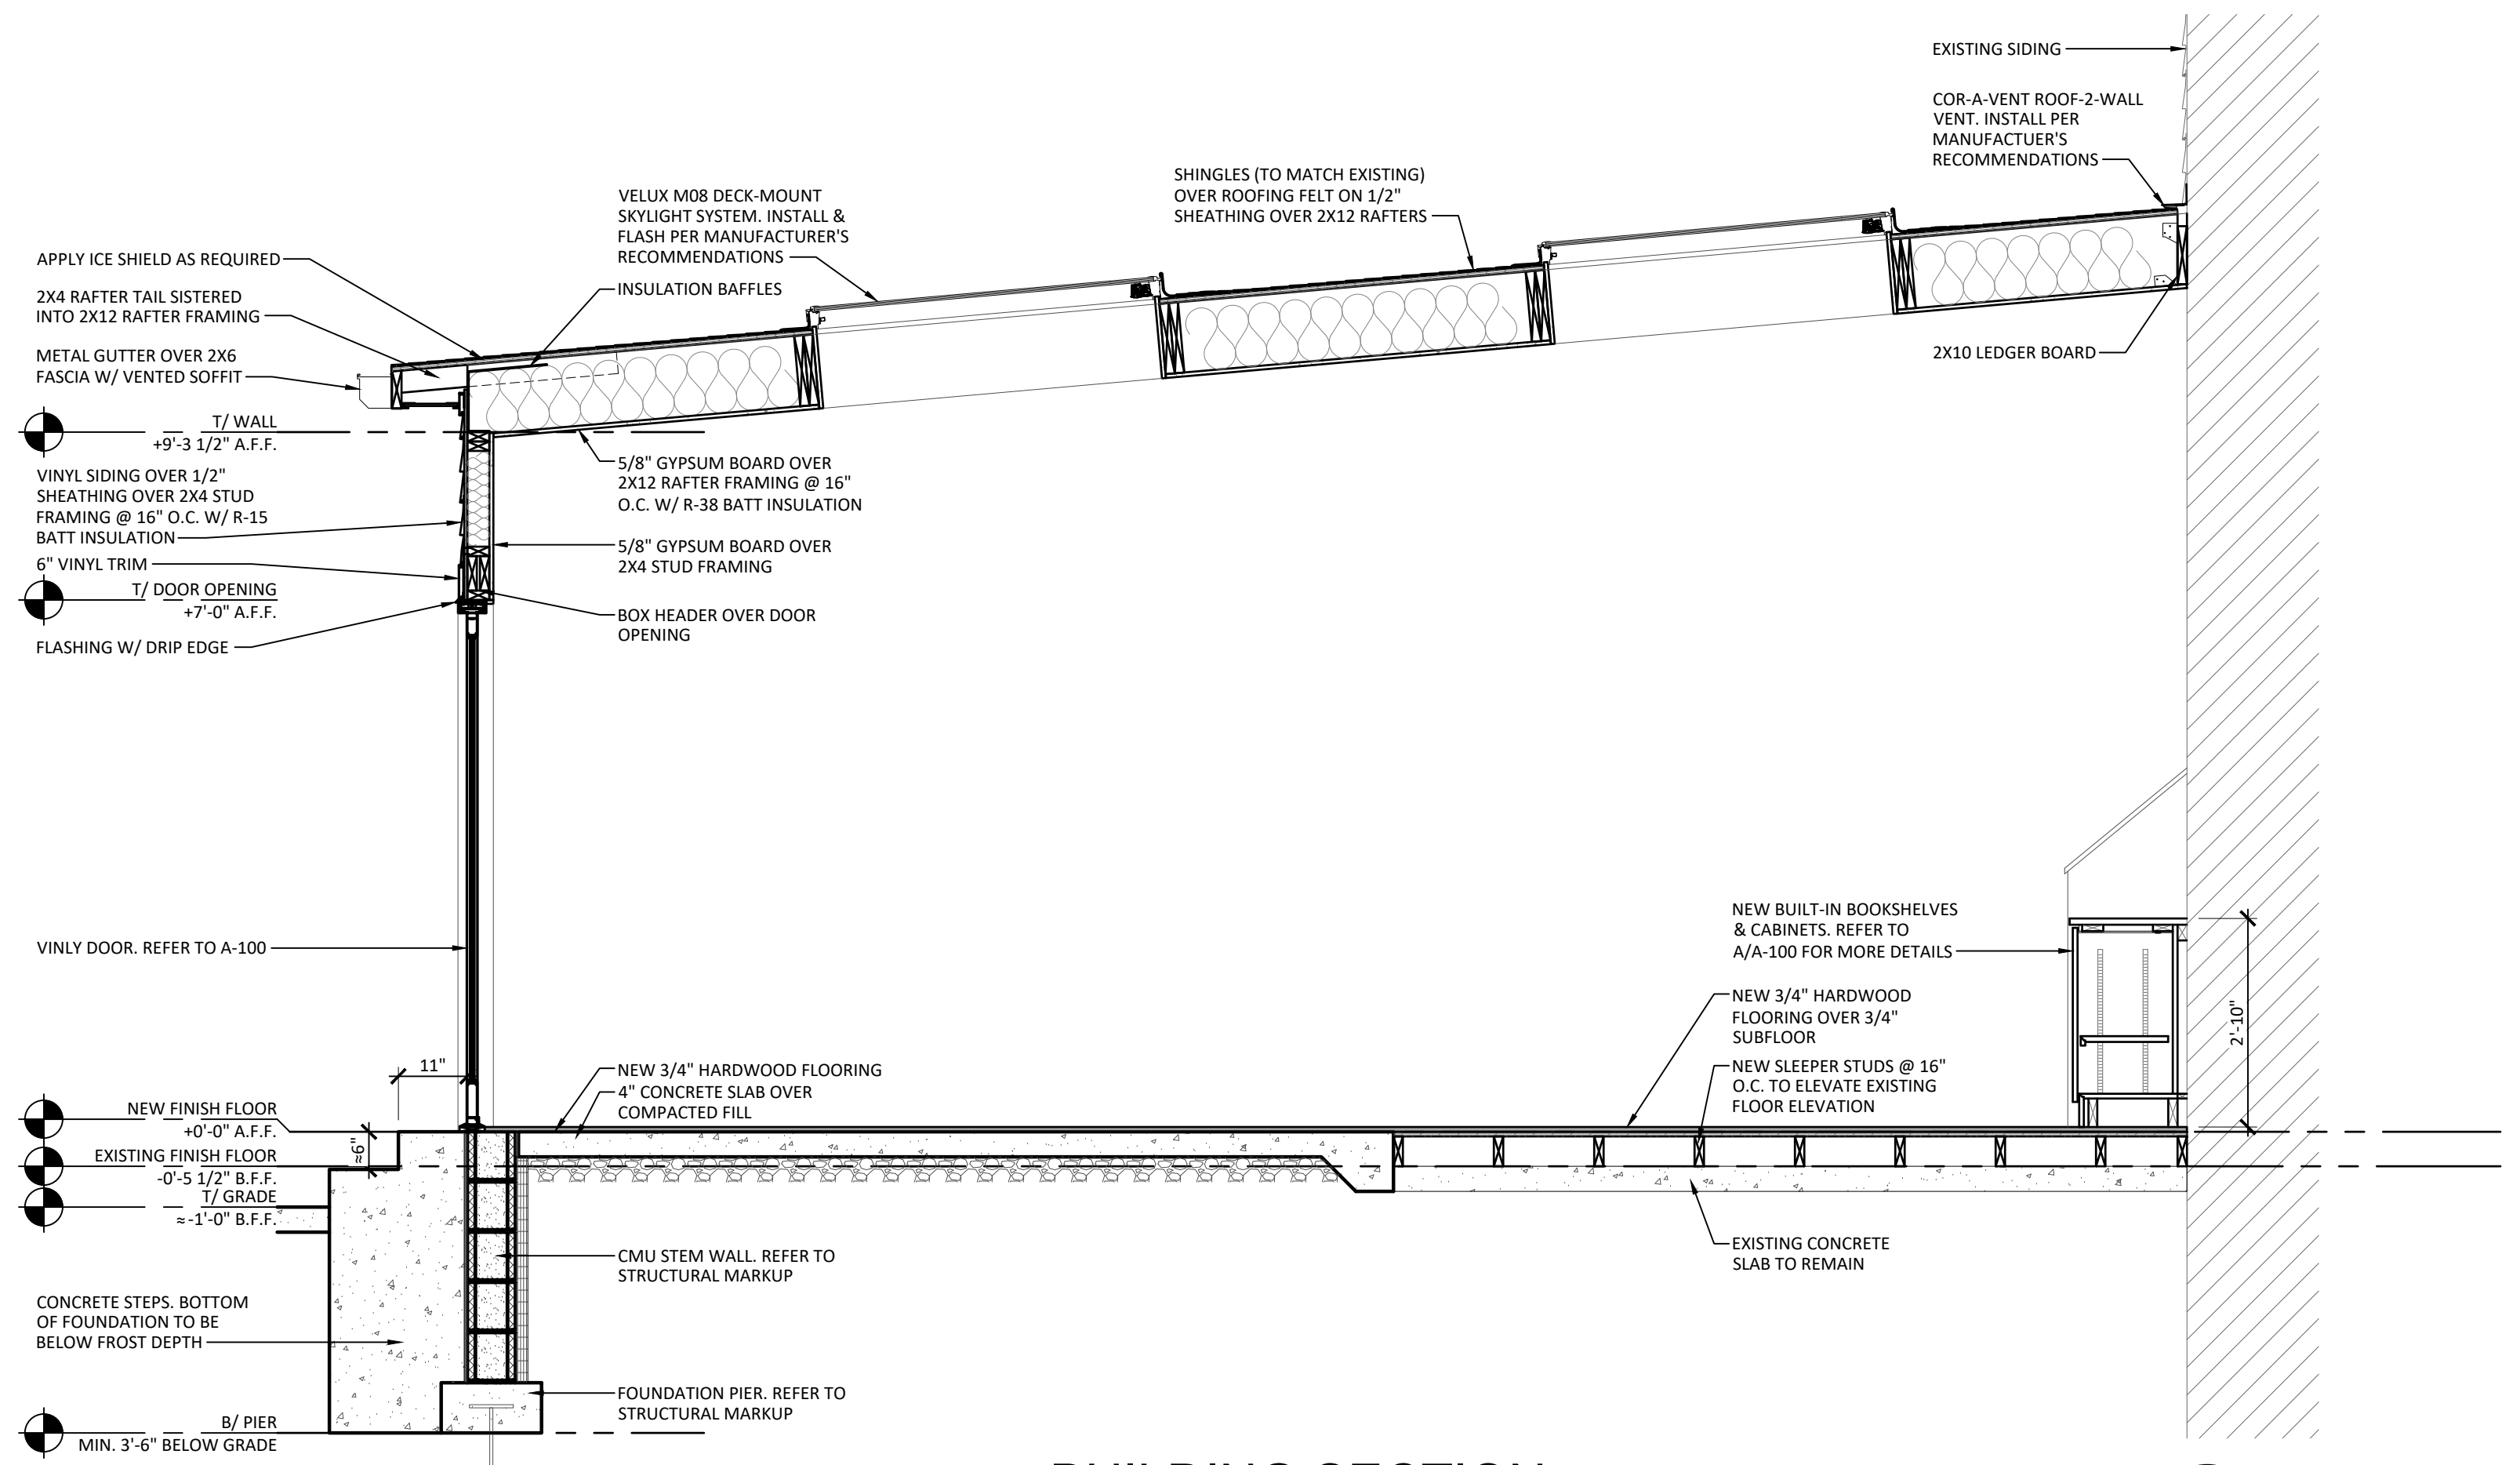

BUILDING SECTION
SCALE: 1/2" = 1'-0"

1
A-400